

工程指示 / 要求簡箋 ENGINEER INSTRUCTIONS(E.I.)

工程指示編號:	EI- 6853	修改版本:	-
	HK-2348		
工程編號:	J 853	工程名稱:	延坪道 (第2期)
收件人:	生統 / 平少	發件人:	Joe Chan
工程項目:	J853 (2期) 圖案花紋 鋁板報價	日期:	18/10/2023

<input type="checkbox"/> 原合約工程包	<input type="checkbox"/> 原合約工程加 / 減賬 QT-	<input type="checkbox"/> 新工程報價 QT-
---------------------------------	--	------------------------------------

信件批核號碼/圖紙參考編號:	批核模具圖紙編號:
客戶指示附件:	管理內部批簽署:

<input type="checkbox"/> 初步鋁料 B.M.	<input type="checkbox"/> 加工拆圖, 然後生產	<input type="checkbox"/> 尺寸表
<input type="checkbox"/> 正式鋁料 B.M.	<input type="checkbox"/> 技術上資料 / 指示	<input type="checkbox"/> 報價
<input type="checkbox"/> 配件 B.M.	<input type="checkbox"/> 樣辦或貨品說明書	<input type="checkbox"/> 分判合約
<input type="checkbox"/> 其他:		

內容: 附上圖案1~圖案8之花紋鋁板尺數資料  
請按附件資料, 提供報價.

完成上列要求日期: 25/10/2023


國內

<input type="checkbox"/> 生產技術總監	<input type="checkbox"/> 連附件	<input type="checkbox"/> 技術部	<input type="checkbox"/> 連附件	<input type="checkbox"/> 生產部	<input type="checkbox"/> 連附件
<input type="checkbox"/> 採購部	<input type="checkbox"/> 連附件	<input checked="" type="checkbox"/> 生產統籌部	<input checked="" type="checkbox"/> 連附件	<input type="checkbox"/> 報關組	<input type="checkbox"/> 連附件
<input type="checkbox"/> 質檢部	<input type="checkbox"/> 連附件	<input type="checkbox"/> 會計部	<input type="checkbox"/> 連附件	<input type="checkbox"/> 機械設計部	<input type="checkbox"/> 連附件
<input type="checkbox"/> 香港辦	<input type="checkbox"/> 連附件	<input type="checkbox"/> 其他:			

香港

<input type="checkbox"/> 行政部	<input type="checkbox"/> 連附件	<input type="checkbox"/> 會計部	<input type="checkbox"/> 連附件	<input type="checkbox"/> 統籌部	<input type="checkbox"/> 連附件	<input type="checkbox"/> 工程部	<input type="checkbox"/> 連附件
<input type="checkbox"/> 採購部	<input type="checkbox"/> 連附件	<input type="checkbox"/> QS部	<input type="checkbox"/> 連附件	<input type="checkbox"/> 地盤管理	<input type="checkbox"/> 連附件	<input type="checkbox"/> 維修部	<input type="checkbox"/> 連附件


*發件人簽署:		*組別成員批核簽署:	
傳遞編號:	HK2348/23	項目經理簽署:	

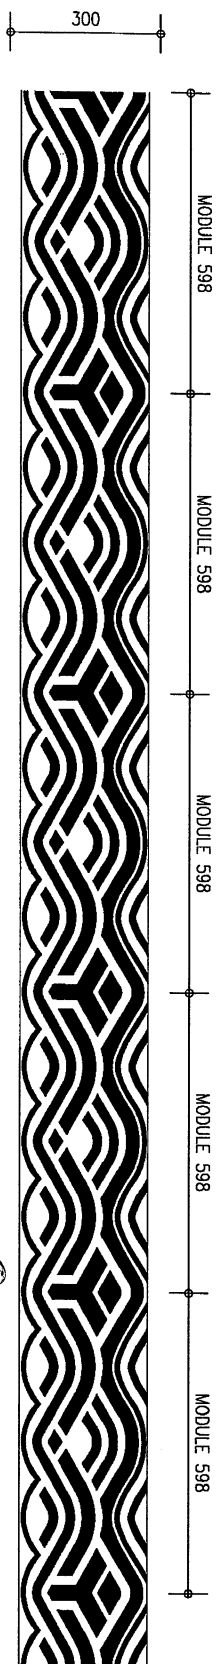

1 ALUMINIUM CLADDING CUTOUT CHINESE PATTERN DETAIL 01



2 ALUMINIUM CLADDING CUTOUT CHINESE PATTERN DETAIL 02

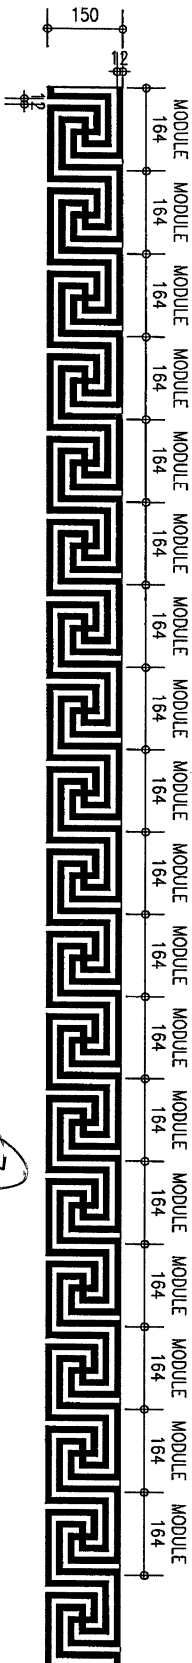

3 ALUMINIUM CLADDING CUTOUT CHINESE PATTERN DETAIL 03

5MM ALUMINIUM CUT-OUT IN PVF2 COATED ALUMINIUM SPRAY TRINAR (4 COAT SYSTEM) GOLD COLOUR  
 ALUMINIUM PANEL IN AL1

**NOTES**  
 SCALE DRAWING. PROVIDED DIMENSIONS ARE TO BE FOLLOWED.  
 READ THIS DRAWING IN CONNECTION WITH GENERAL ARCHITECTURAL PLANS, STRUCTURAL PLANS, MECHANICAL PLANS, ELECTRICAL PLANS, AND ALL OTHERS. DISCREPANCY FOUND THEREIN, CONTRACTOR SHALL BE NOTIFIED IMMEDIATELY OF ANY DISCREPANCY FOUND THEREIN. CONTRACTOR'S RESPONSIBILITY OF THIS DRAWING RESERVED BY ARCHITECT.

REVISIONS		REVISED BY	DATE	REASON
01	16/7/22	TERRIS	16/7/22	ISSUE FOR TENDER

NO.	DATE	REVISIONS	REVISED BY	DATE	REASON
01	16/7/22	TERRIS	16/7/22	ISSUE FOR TENDER	




**WONG TUNG & PARTNERS LIMITED**  
 ARCHITECTS & PLANNERS  
 5th Floor, Cityplace 3, Tsim Sha Tsui, Hong Kong  
 T 852-2809 9888 F 852-2519 1728 www.wongtung.com

**PROJECT:**  
 PROPOSED RESIDENTIAL DEVELOPMENT AT NKIL 6542, TAI WO PING KOWLOON


**TITLE:**  
 HOUSE ALUMINIUM CHINESE PATTERN DETAIL - 1

DATE	01/07/22	SCALE	1:50
DRAWING NO.	T/A73/81	ISSUED BY	01

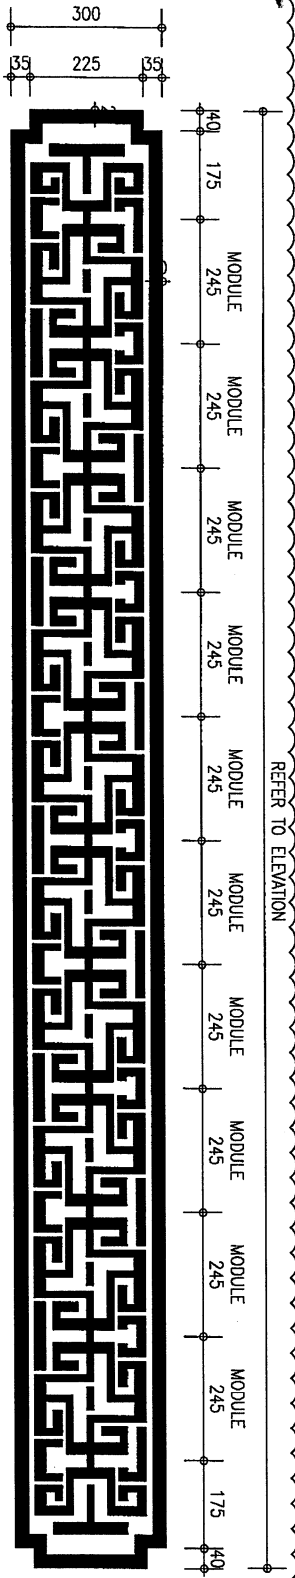


REFER TO ELEVATION

1 ALUMINIUM CLADDING CUTOUT CHINESE PATTERN DETAIL 02  
HOUSE A (TYPE F)

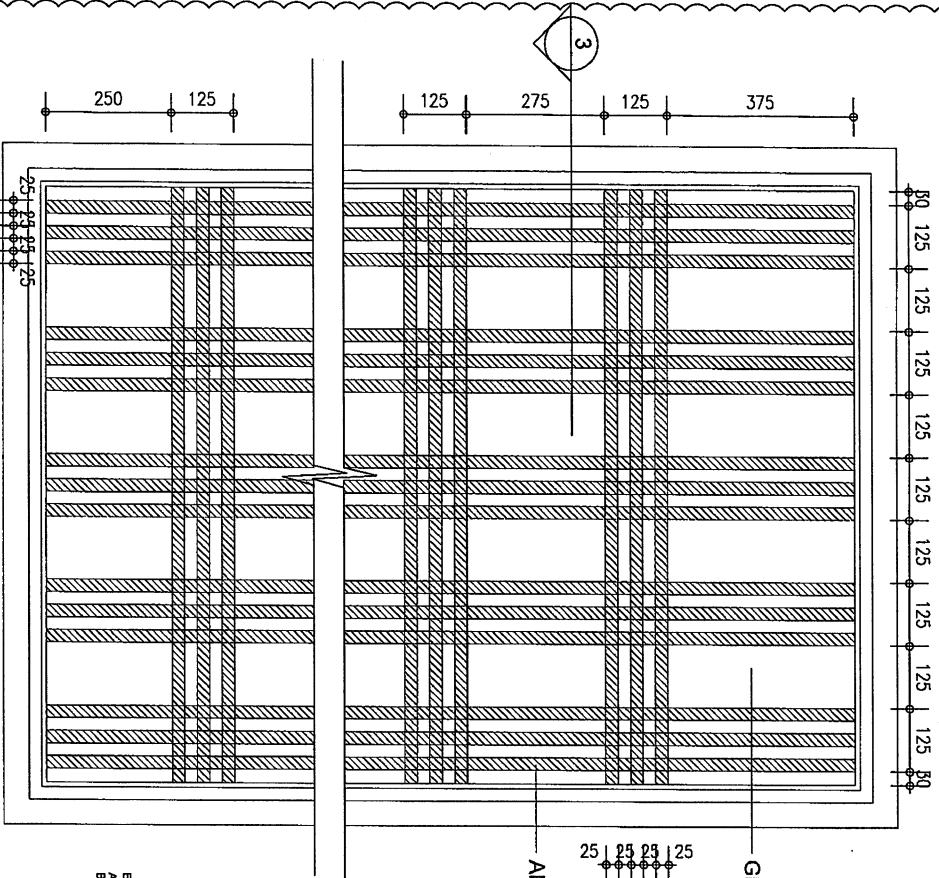

2 ALUMINIUM GRILLE FEATURES WINDOW DETAIL 01  
HOUSE A (TYPE F)

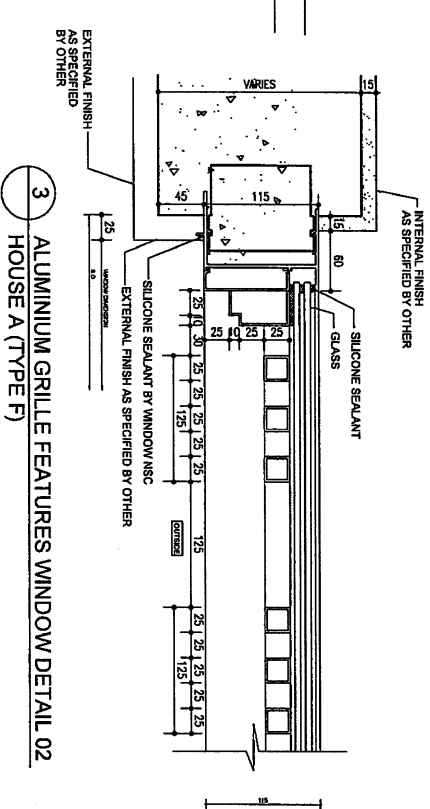

3 ALUMINIUM GRILLE FEATURES WINDOW DETAIL 02  
HOUSE A (TYPE F)

NOTES  
DO NOT SCALE DRAWING. PROVIDED DIMENSIONS SHALL BE USED FOR CONSTRUCTION.  
REVISIONS FROM THIS DRAWING IN CONNECTION WITH GENERAL ARCHITECTURAL PLANS, STRUCTURAL PLANS, ELECTRICAL PLANS, MECHANICAL PLANS, PLUMBING PLANS, AND OTHERS SHALL BE NOTIFIED IMMEDIATELY OF ANY DISCREPANCY FOUND THEREIN.  
COPYRIGHT OF THIS DRAWING RESERVED BY ARCHITECTS.

5MM ALUMINIUM CUT-OUT IN PVF2  
COATED ALUMINIUM SPRAY TRIMAR  
(4 COAT SYSTEM) GOLD COLOUR

ALUMINIUM PANEL IN AL1

NO.	DATE	REVISIONS	BY	CHECKED	APPROVED
01	01/05/22	TENDER ADDENDUM NO.1			



WONG TUNG & PARTNERS LIMITED  
10th Floor, Cheong Cheong Building, 100 Queen's Road Central, Hong Kong  
Tel: 852-2802 8888 Fax: 852-2513 1728 www.wongtung.com

PROJECT:  
PROPOSED RESIDENTIAL DEVELOPMENT AT NIKIL 6542, TAI WO PING KOWLOON


TITLE:  
HOUSE ALUMINIUM CHINESE PATTERN DETAIL - 2

DATE	BY	CHECKED	NO.	DATE	BY	CHECKED	NO.
01/05/22							

TENDER ADDENDUM NO. 1

31740 T/A73/82 01

5

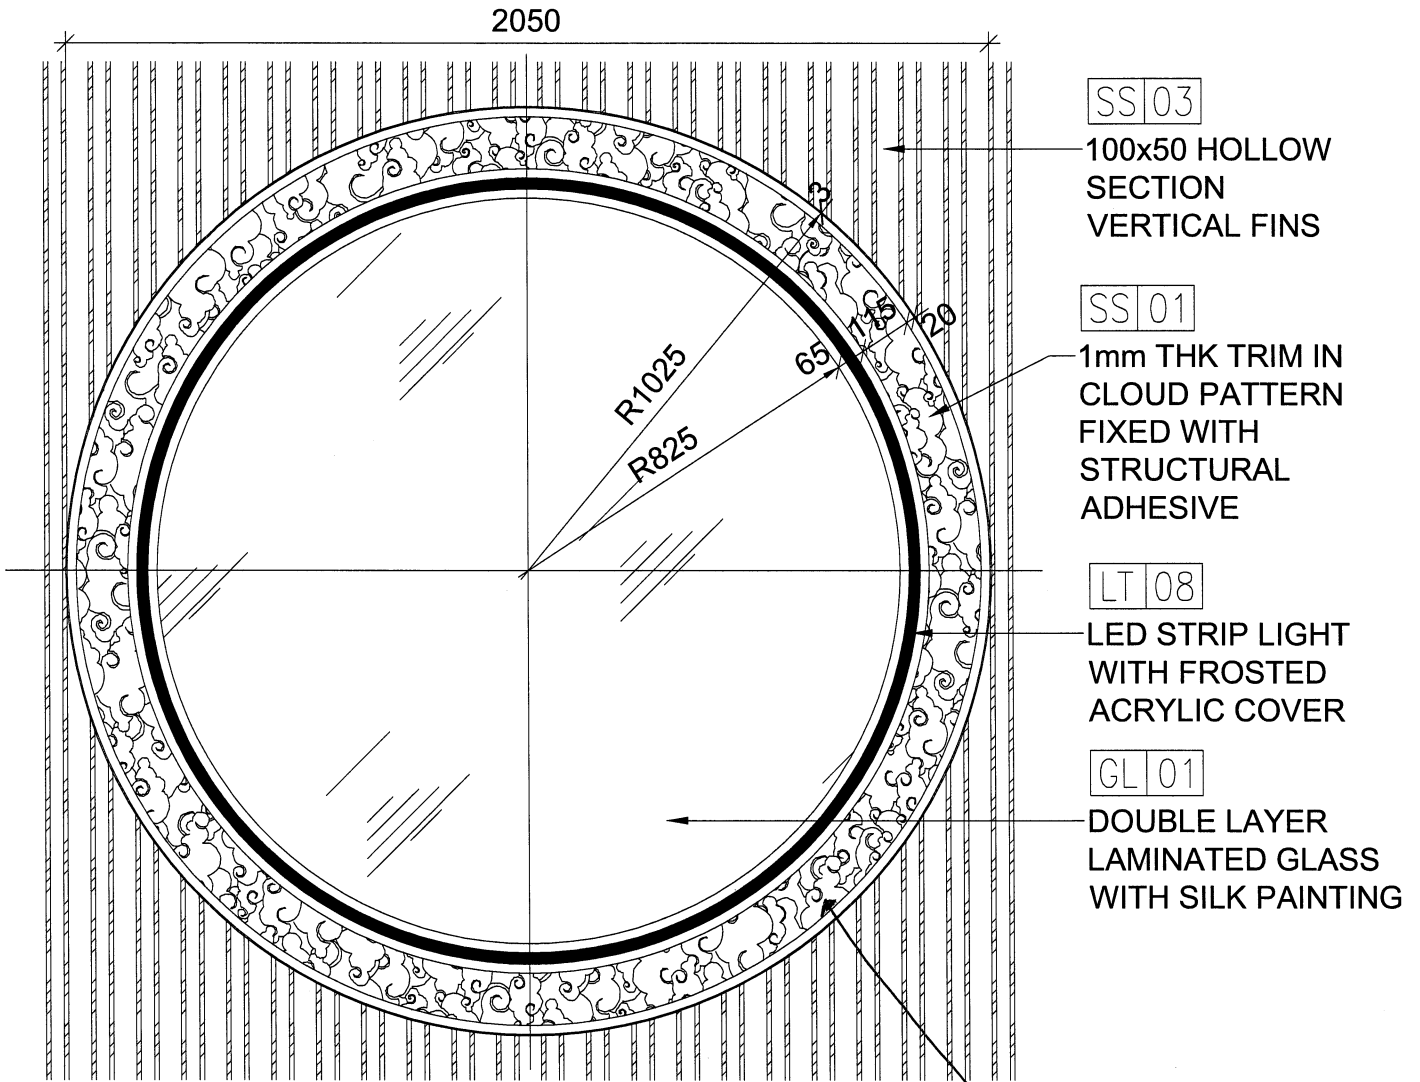

SS 03

100x50 HOLLOW SECTION  
VERTICAL FINS

SS 01

1mm THK TRIM IN  
CLOUD PATTERN  
FIXED WITH  
STRUCTURAL  
ADHESIVE

LT 08


LED STRIP LIGHT  
WITH FROSTED  
ACRYLIC COVER

GL 01

DOUBLE LAYER  
LAMINATED GLASS  
WITH SILK PAINTING

# DECORATIVE WALL MURAL ELEVATION


SCALE 1:25

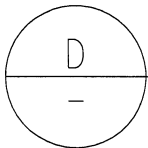

花纹



①


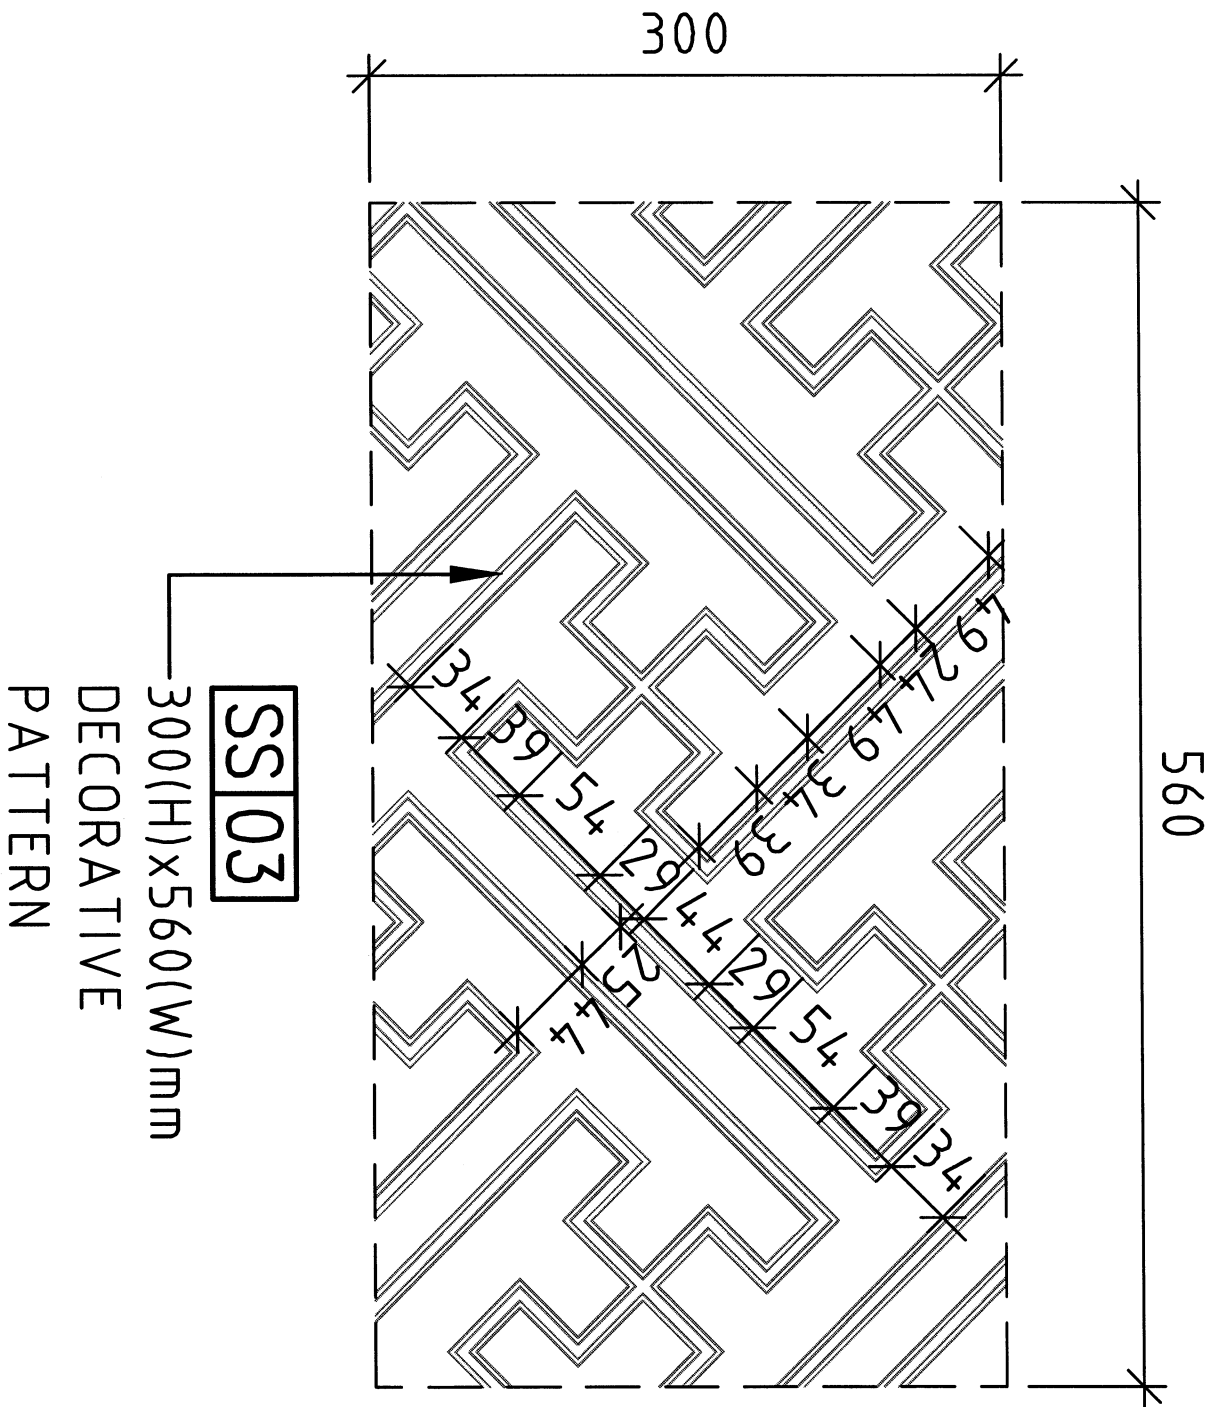


600 X 2100

共 3 片

25 mm / 3/16" X 1/2"

2

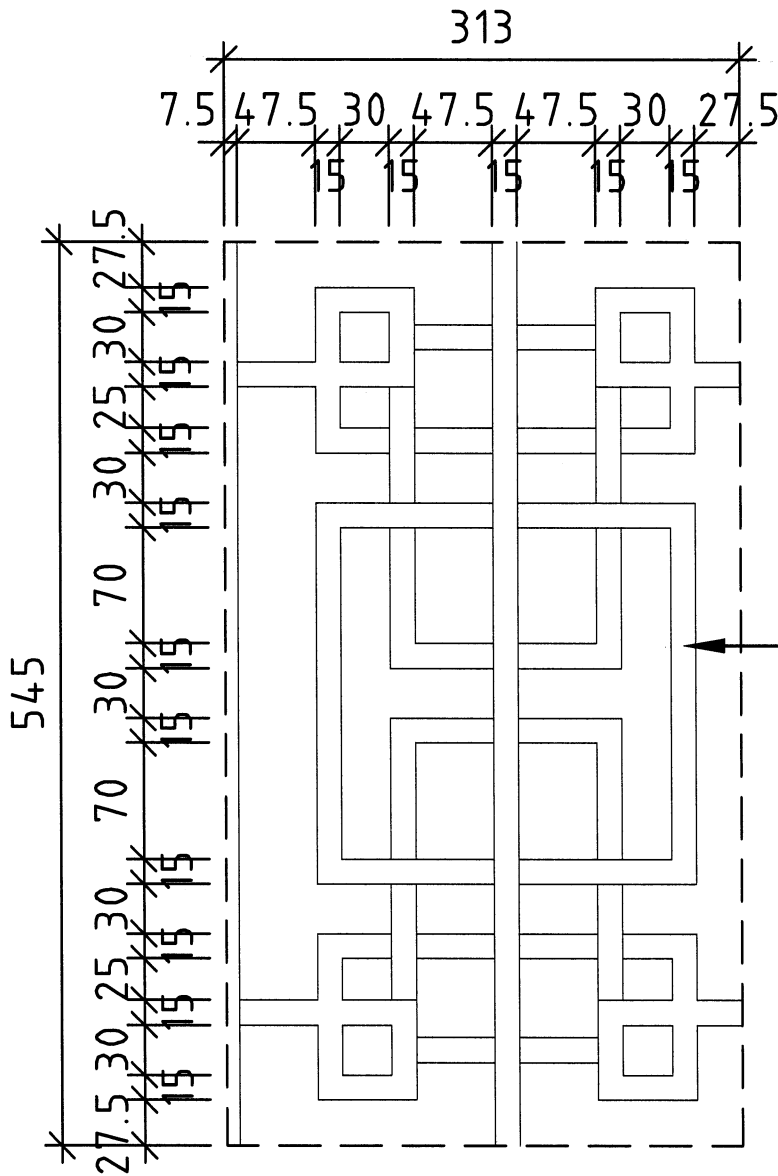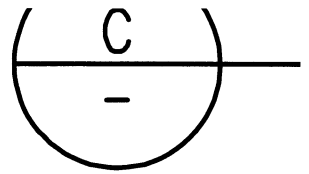


1000 X 1000

共 2 件

SS 03

545(H)x313(W)mm  
DECORATIVE  
PATTERN

25 mm 鋁板

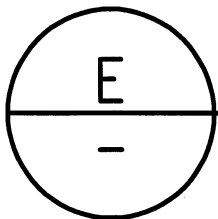

# BLOW-UP DETAIL

SCALE 1:10

